
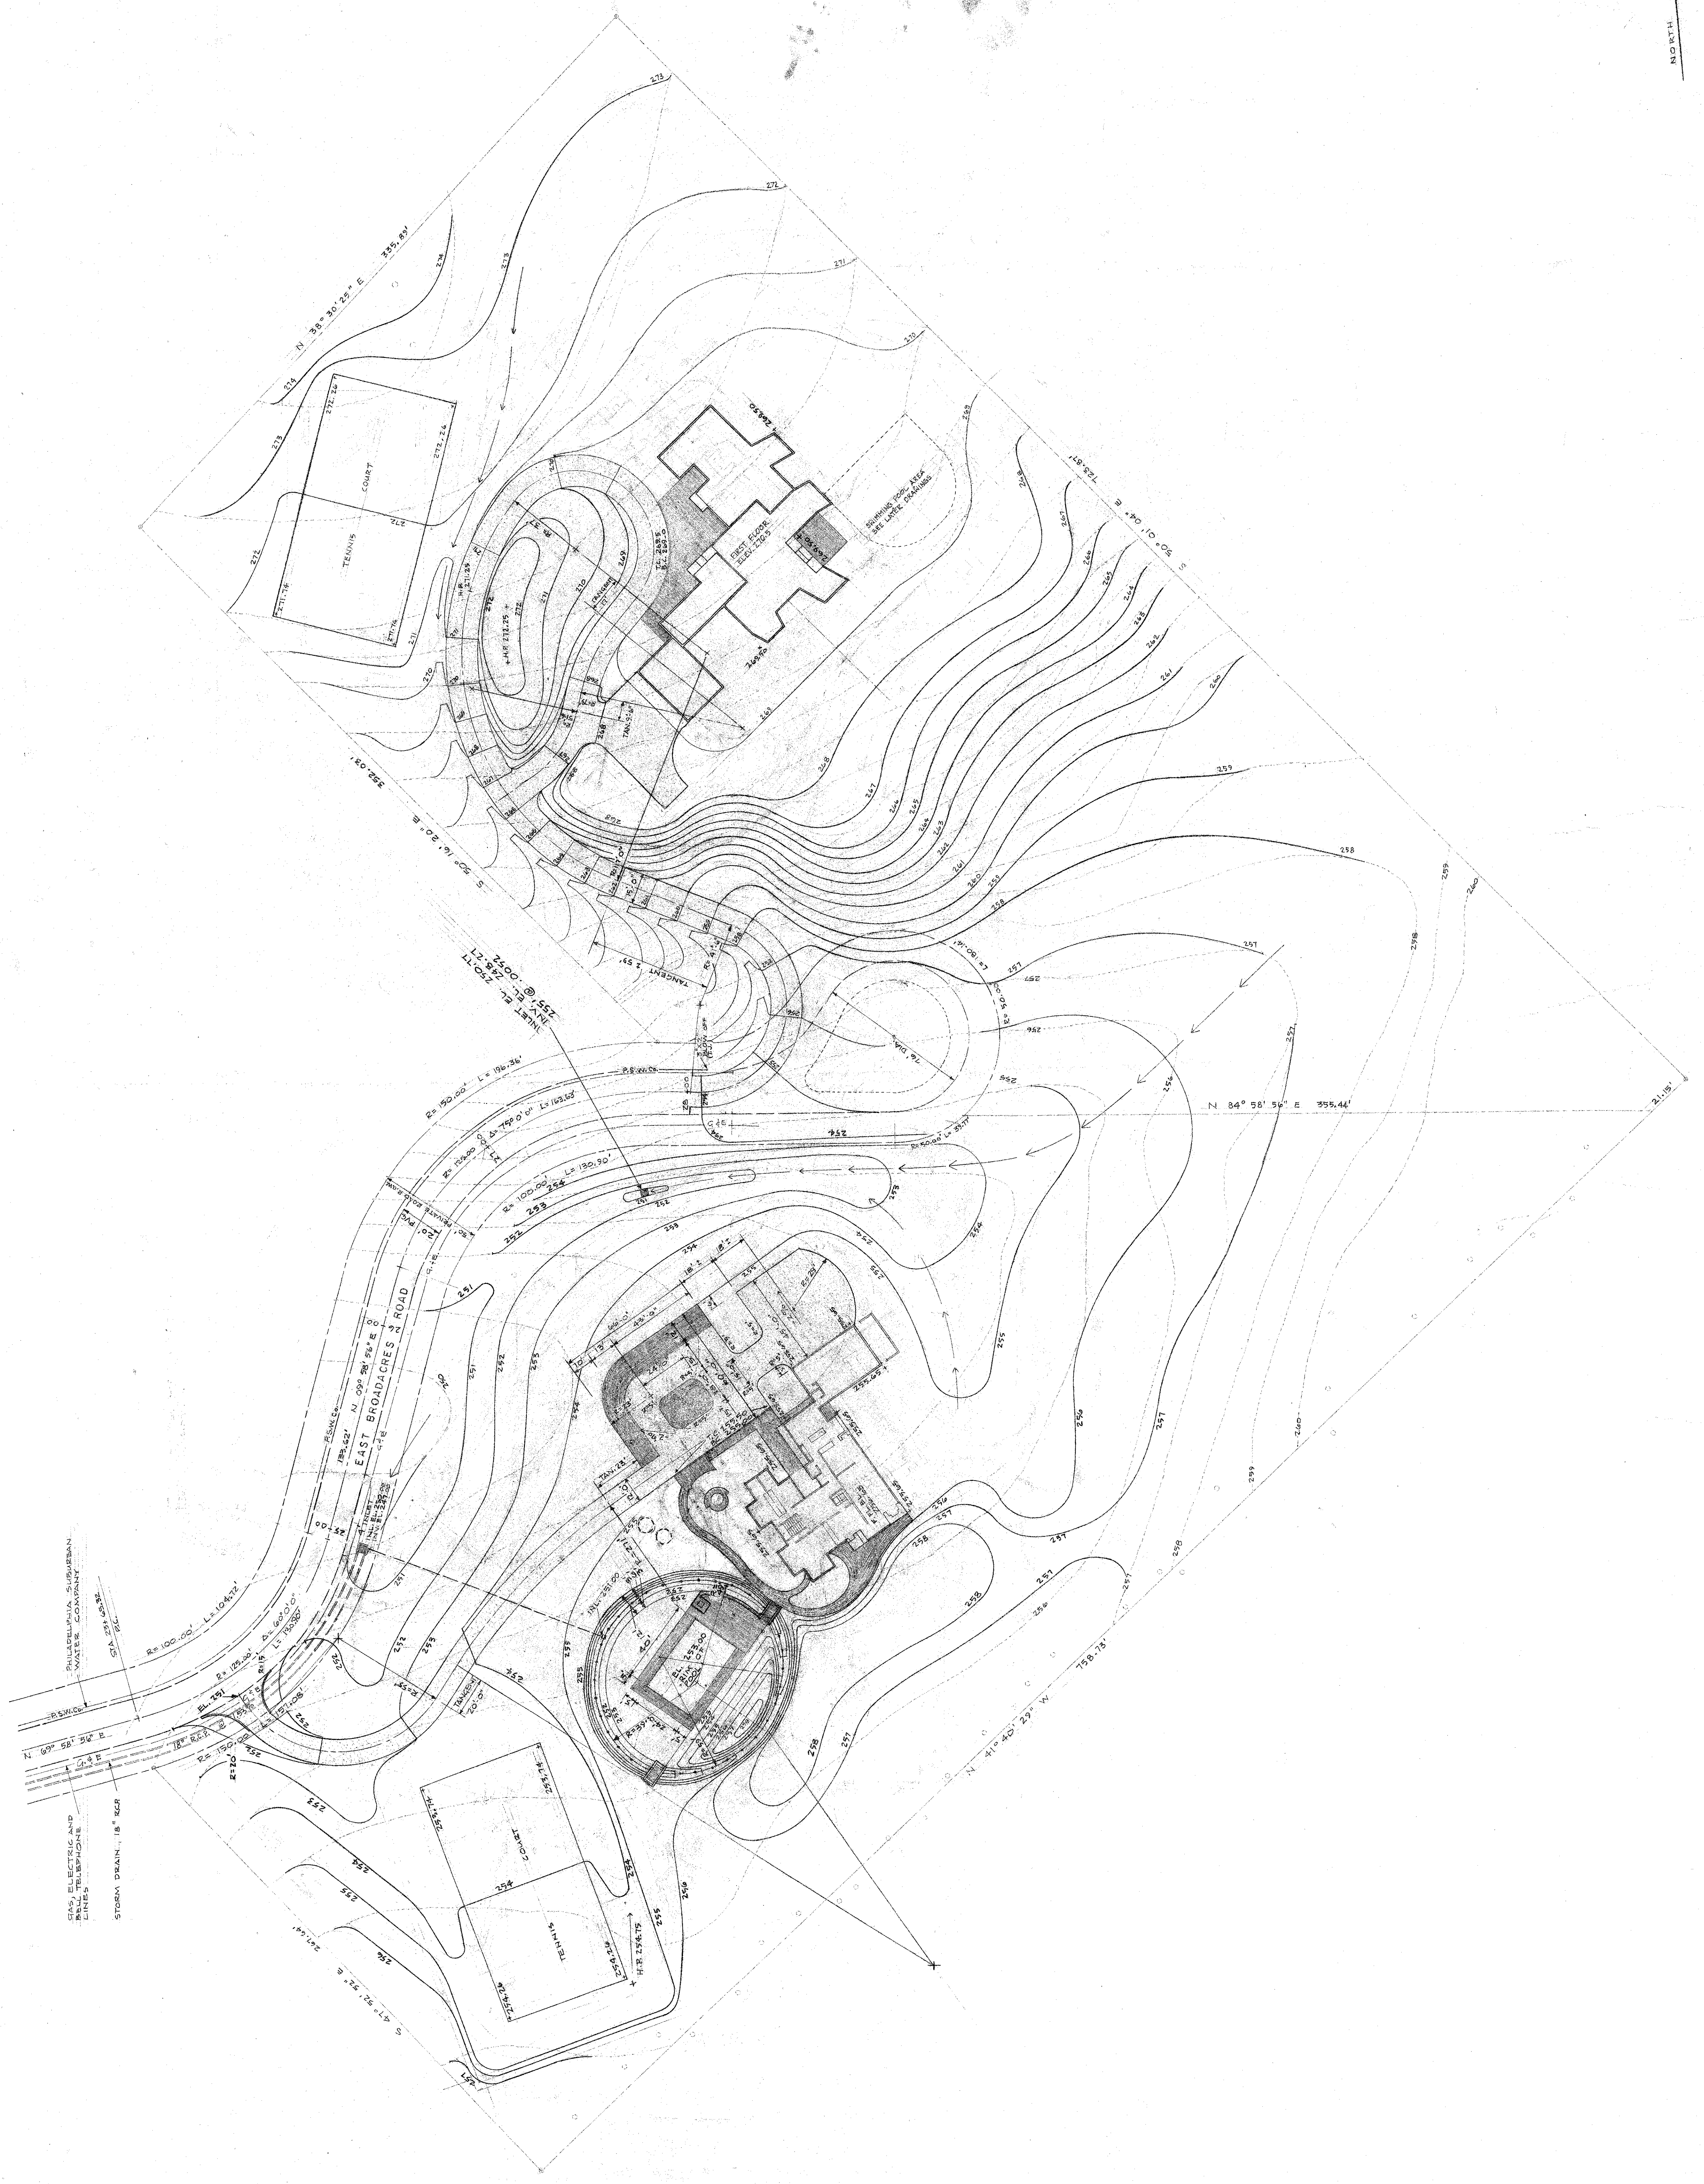 


MAY 7 1973
12-22-73
DEC 21
NOV 6
OCT 25
OCT 15
8-31-72
DATE: 8-18-72
SCALE: 1" = 50'

DRAWING NO. A

SITE PLAN
LOUIS I. MANN ARCHITECT
1501 WALNUT ST. PHILADELPHIA, PENNSYLVANIA



PHILADELPHIA SUBURBAN
WATER COMPANY
ELECTRIC AND
TELEPHONE
LINES
STORM DRAIN, 18" RCP

PLANNED
NJ 099 280 222 E
EAST BROADACRES N ROAD

PIET 2000
PIET 2000
